



3 EXHAUST VENT
SCALE 1" = 1'-0"

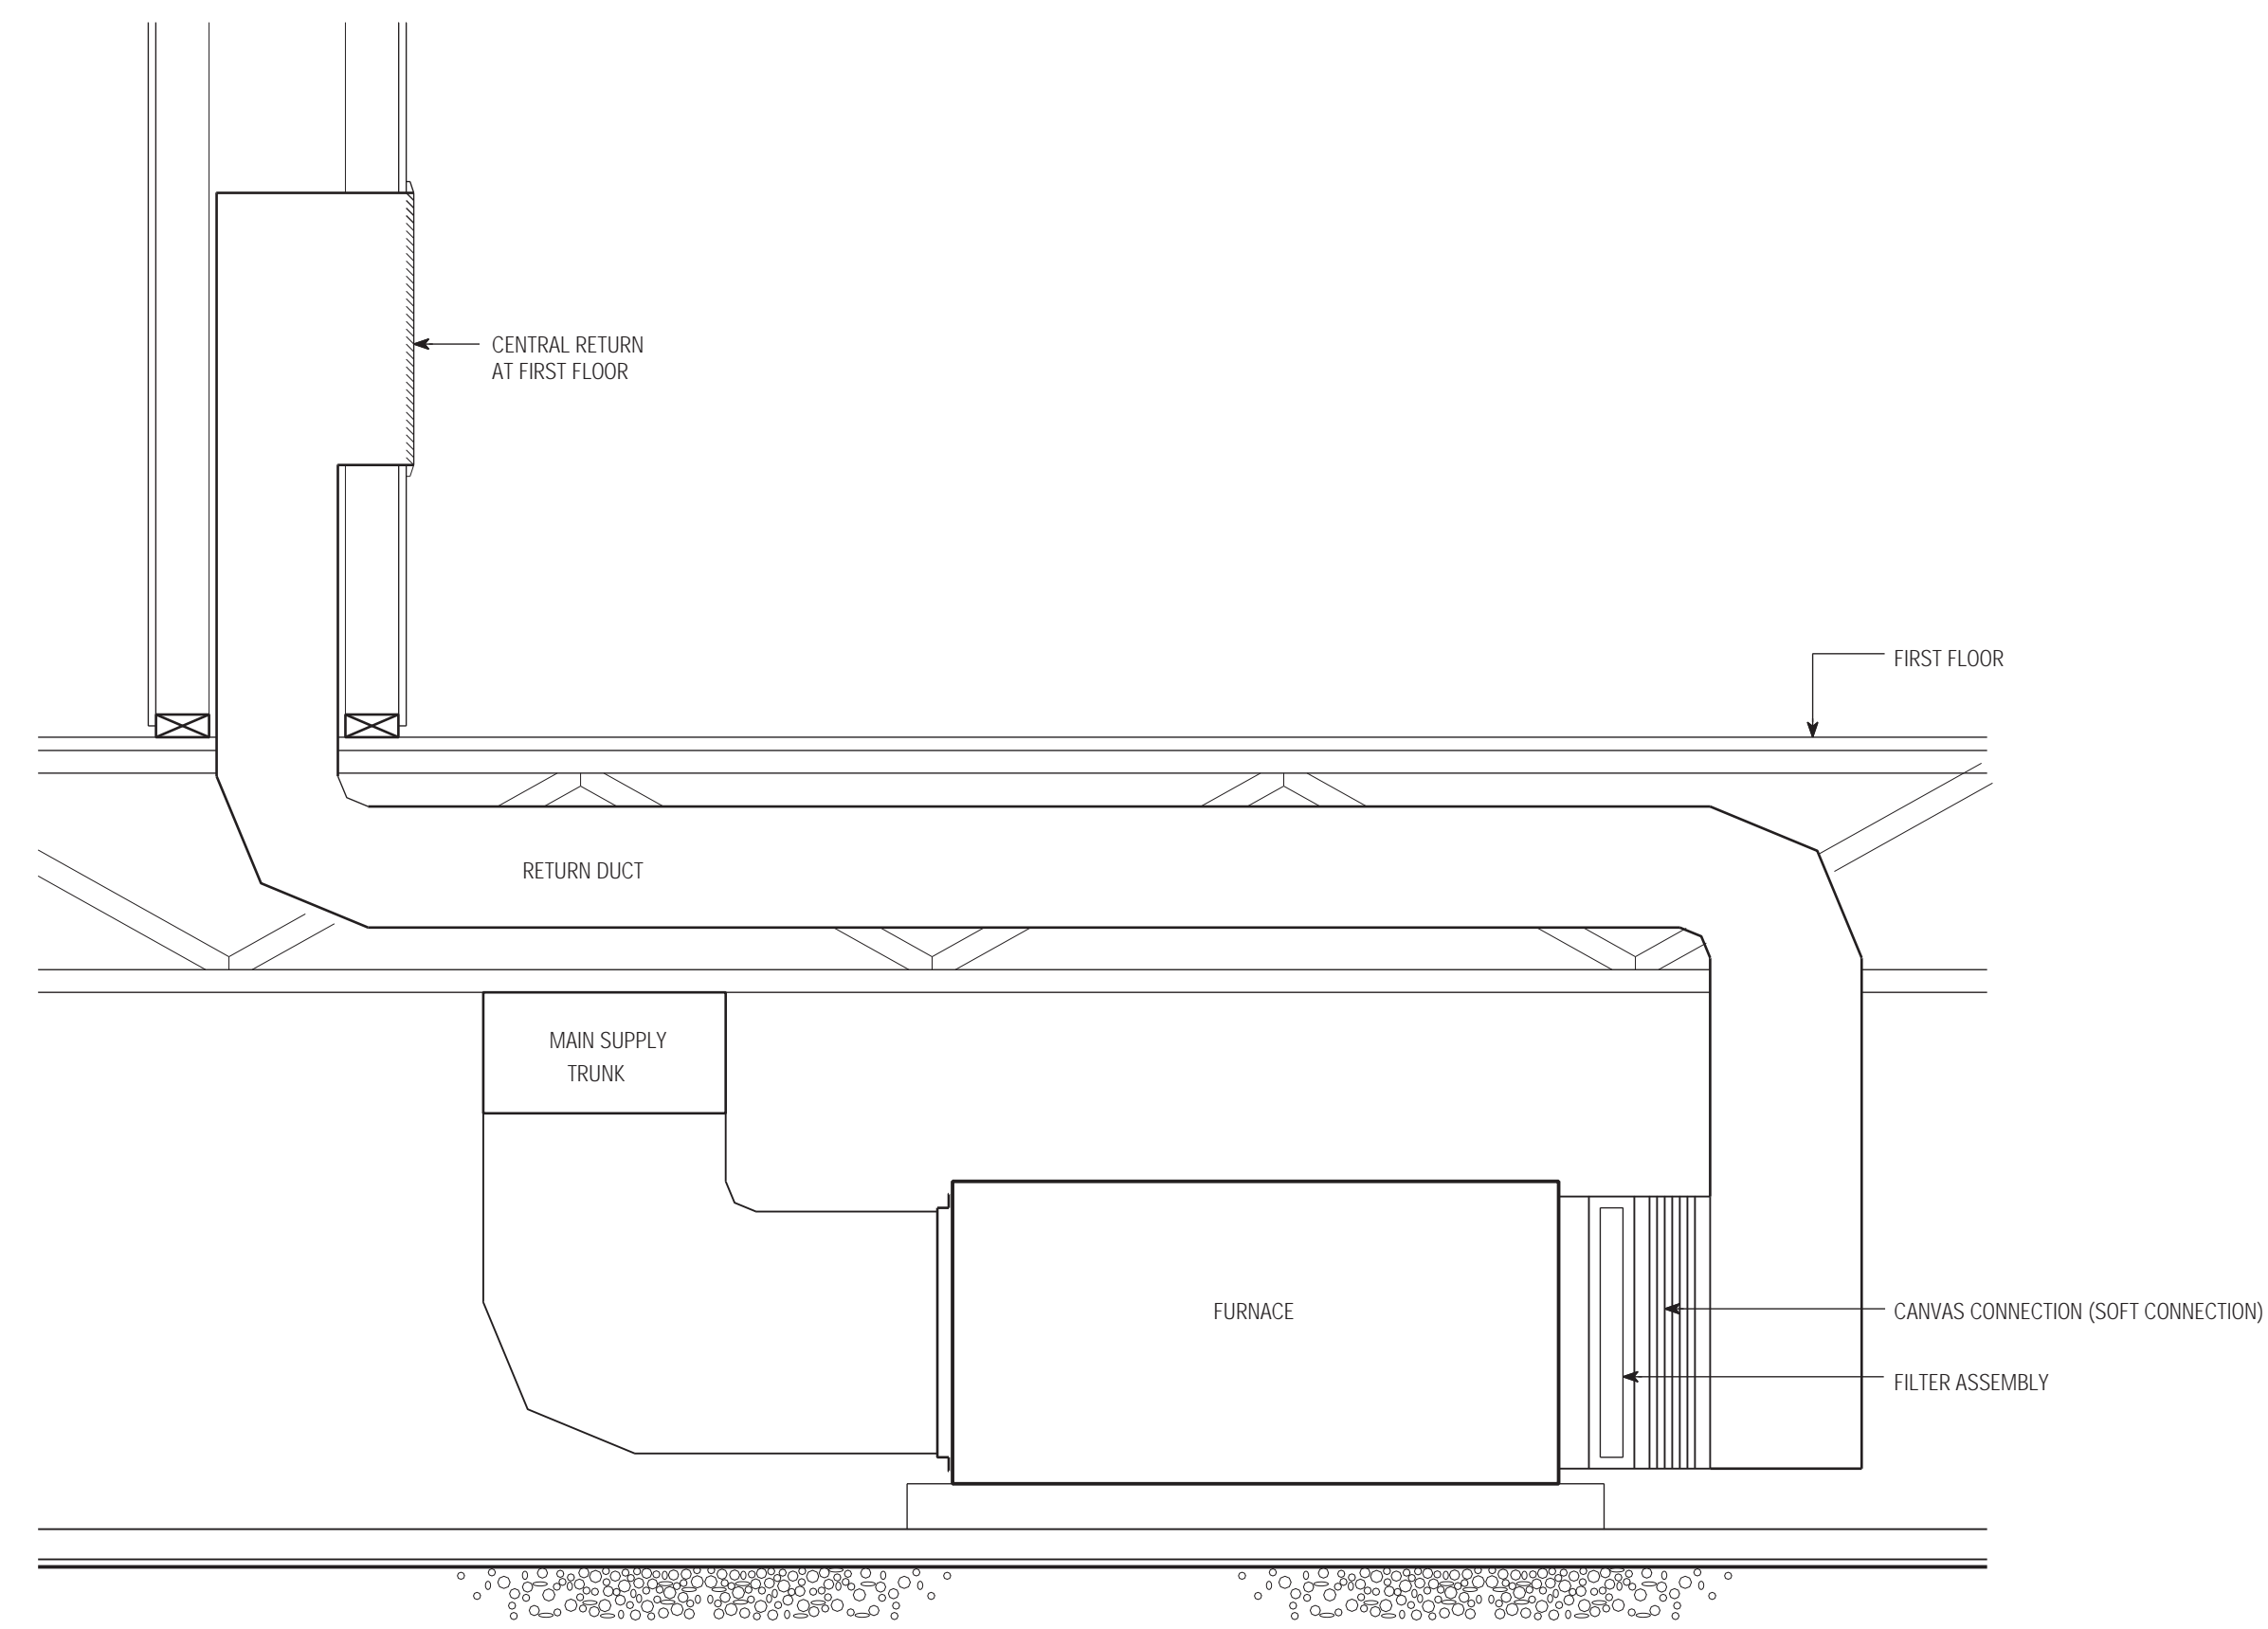

2 FURNACE DETAIL
SCALE 1" = 1'-0"

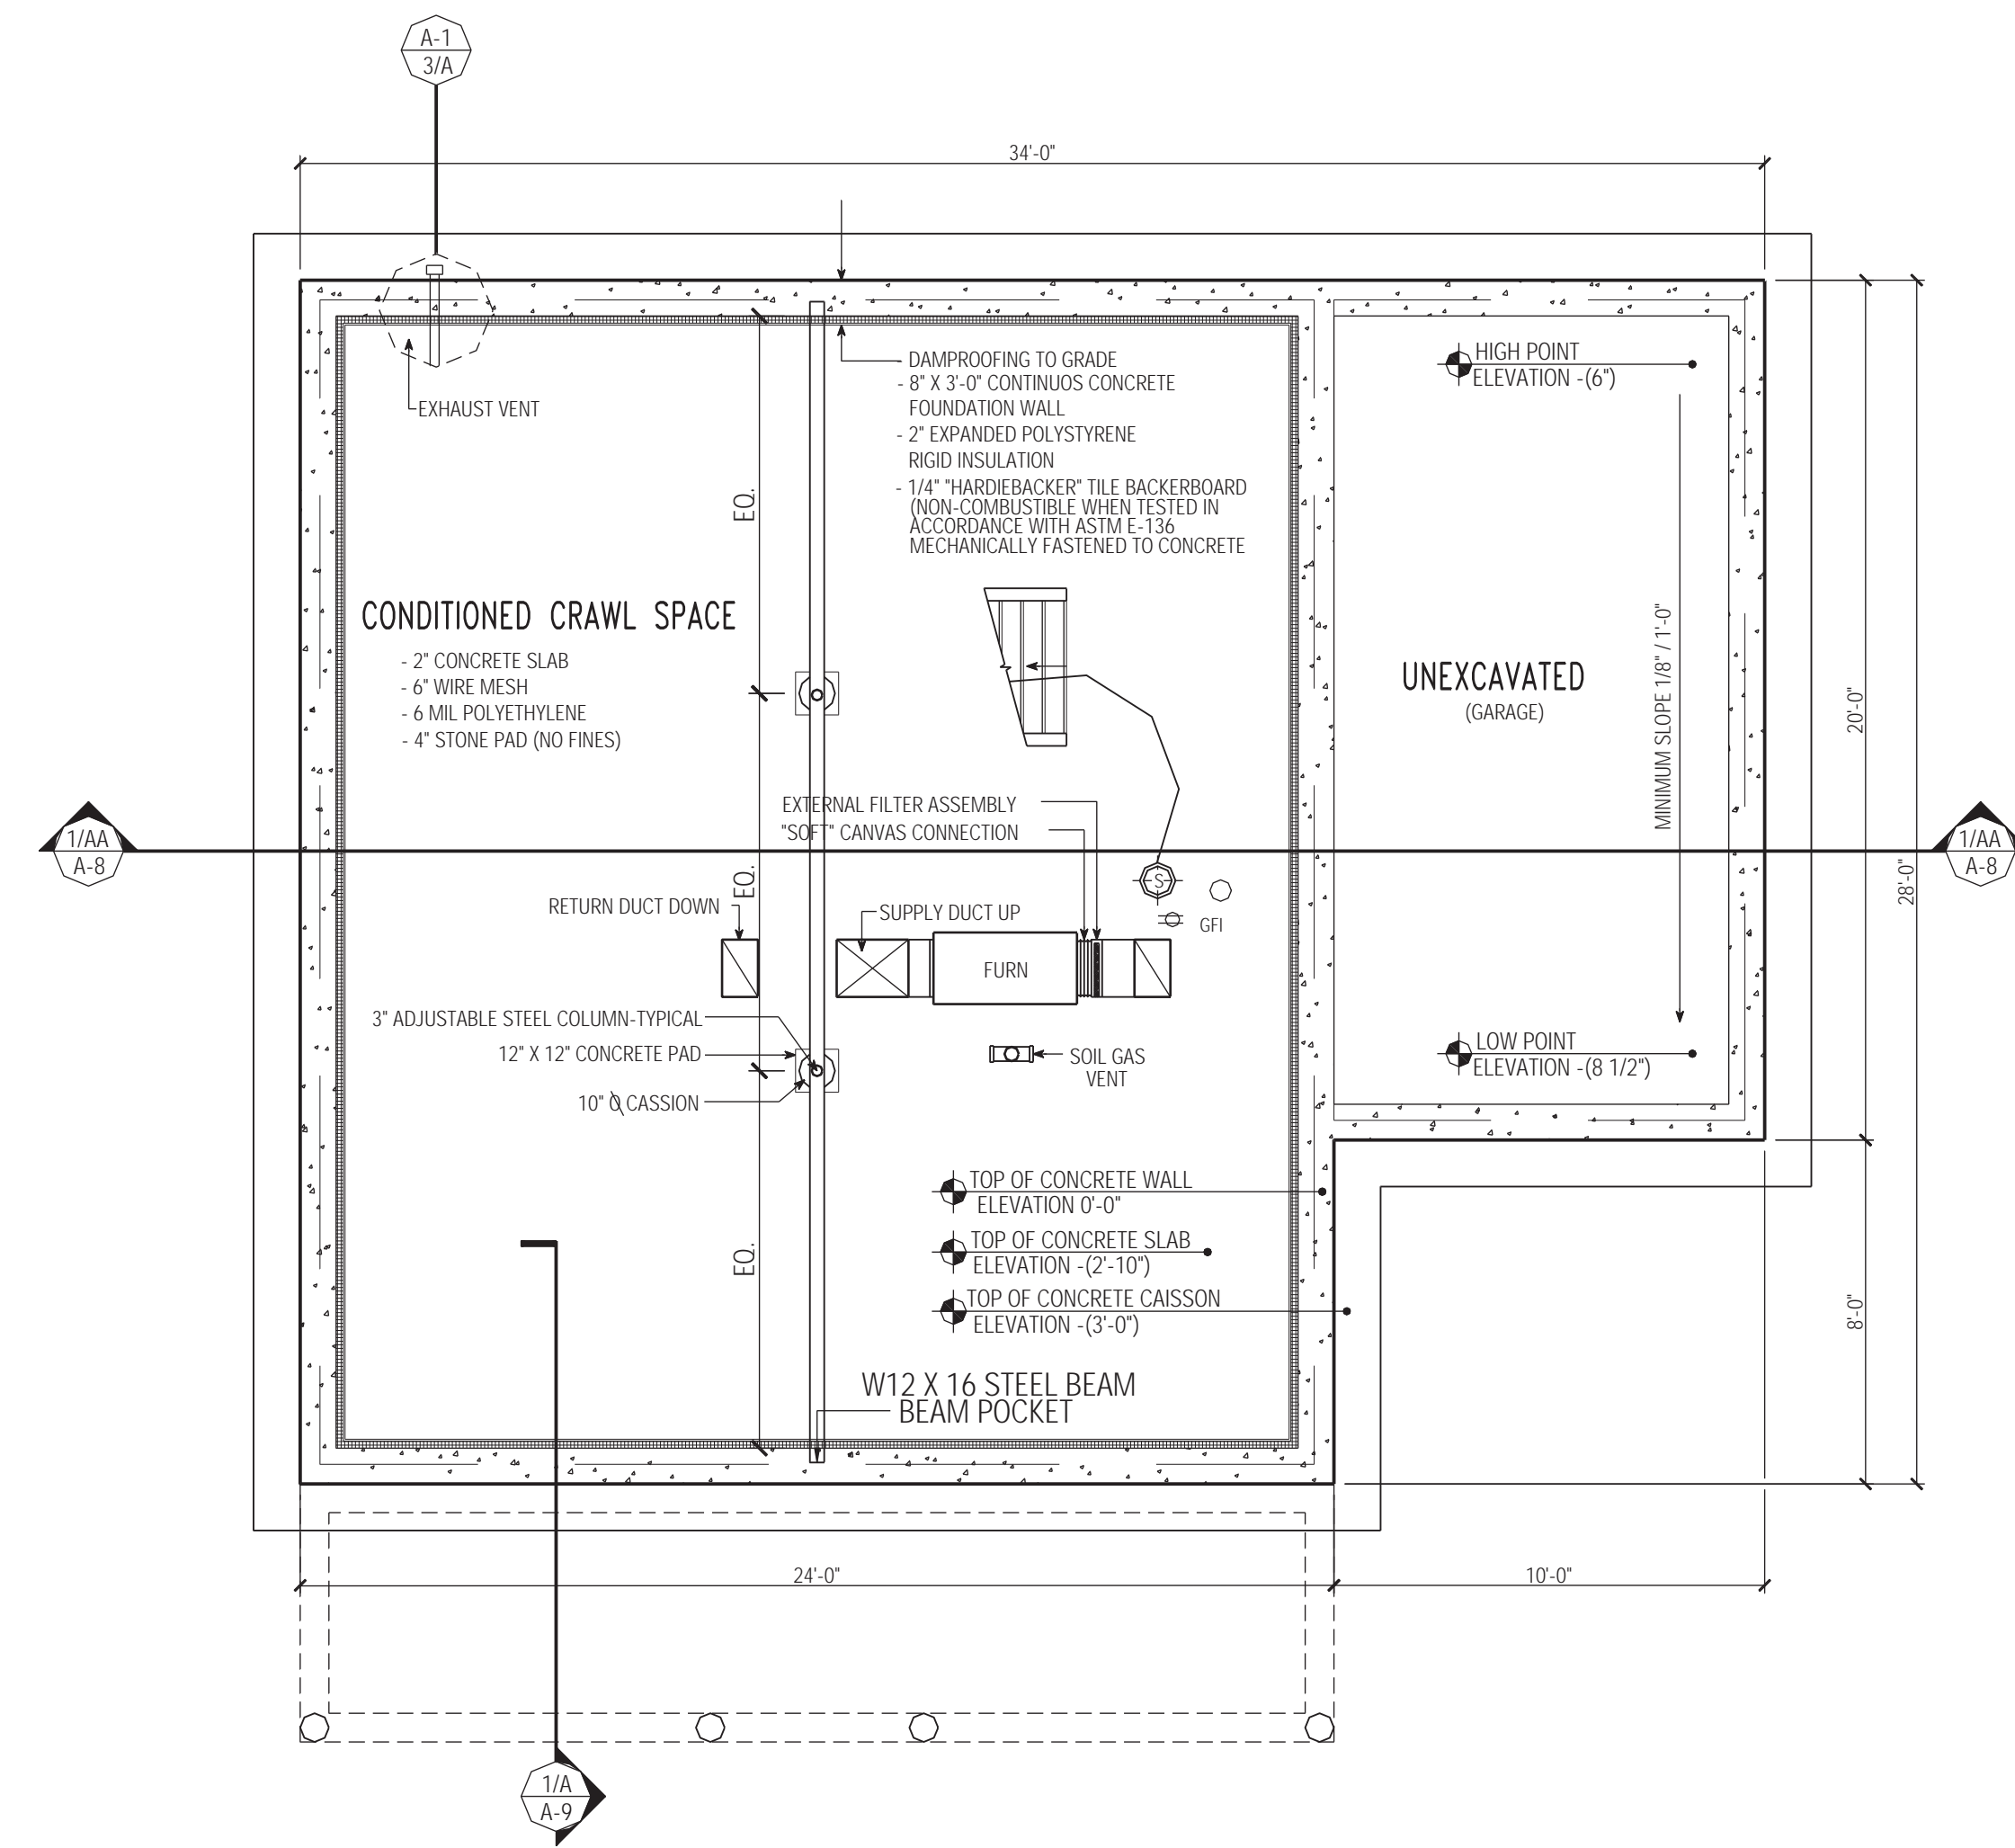

1 FOUNDATION PLAN
SCALE 1/4" = 1'-0"

